


The processing centre Flow Diagram

Homestead Growers and Co-op members bring their produce to the receiving office. The produce is weighed, counted and inspected for quality. Poor quality elements are rejected. All accepted produce is paid for by means of a coupon to be cashed at the Accounts office.

Received and accepted produce goes into the cold room for temporary storage. Stored produce then goes to the sorting tables where it is cleaned of unwanted material and handed over to be washed. Washed produce could also then either be packed in bulk or individually for the market or its preliminary processed (peeled and diced) and packaged. Packed produce goes either to the fridge or the freezer. Some washed produce goes to the kitchen where it is processed further into enhanced products. Completed enhanced products goes to the ready for market produce store.

From the Freezer, fridge, dry veg store or Ready for Market Store the produce is then shipped to the various points of sale.

- Accepted vegetables and fruit is stored temporarily in the cold room and then sorted
- Fresh vegetables and fruit brought in by Homestead Growers or Co-op Members to the Receiving Office to be inspected, counted or weighed
- Sorted vegetables and fruit is washed. Then it can be bulk packed for market, receive preliminary processing (peeling and dicing), packaged or is sent onto the kitchen
- Semi-processed vegetables is processed further by cooking, pickling or preserving to enhanced products which is then bottled.
- Processed vegetables and fruit is sent to the freezer, fridge, dry veg store or market ready product store for shipment to the market
- Processed vegetables and fruit is sent to the various markets

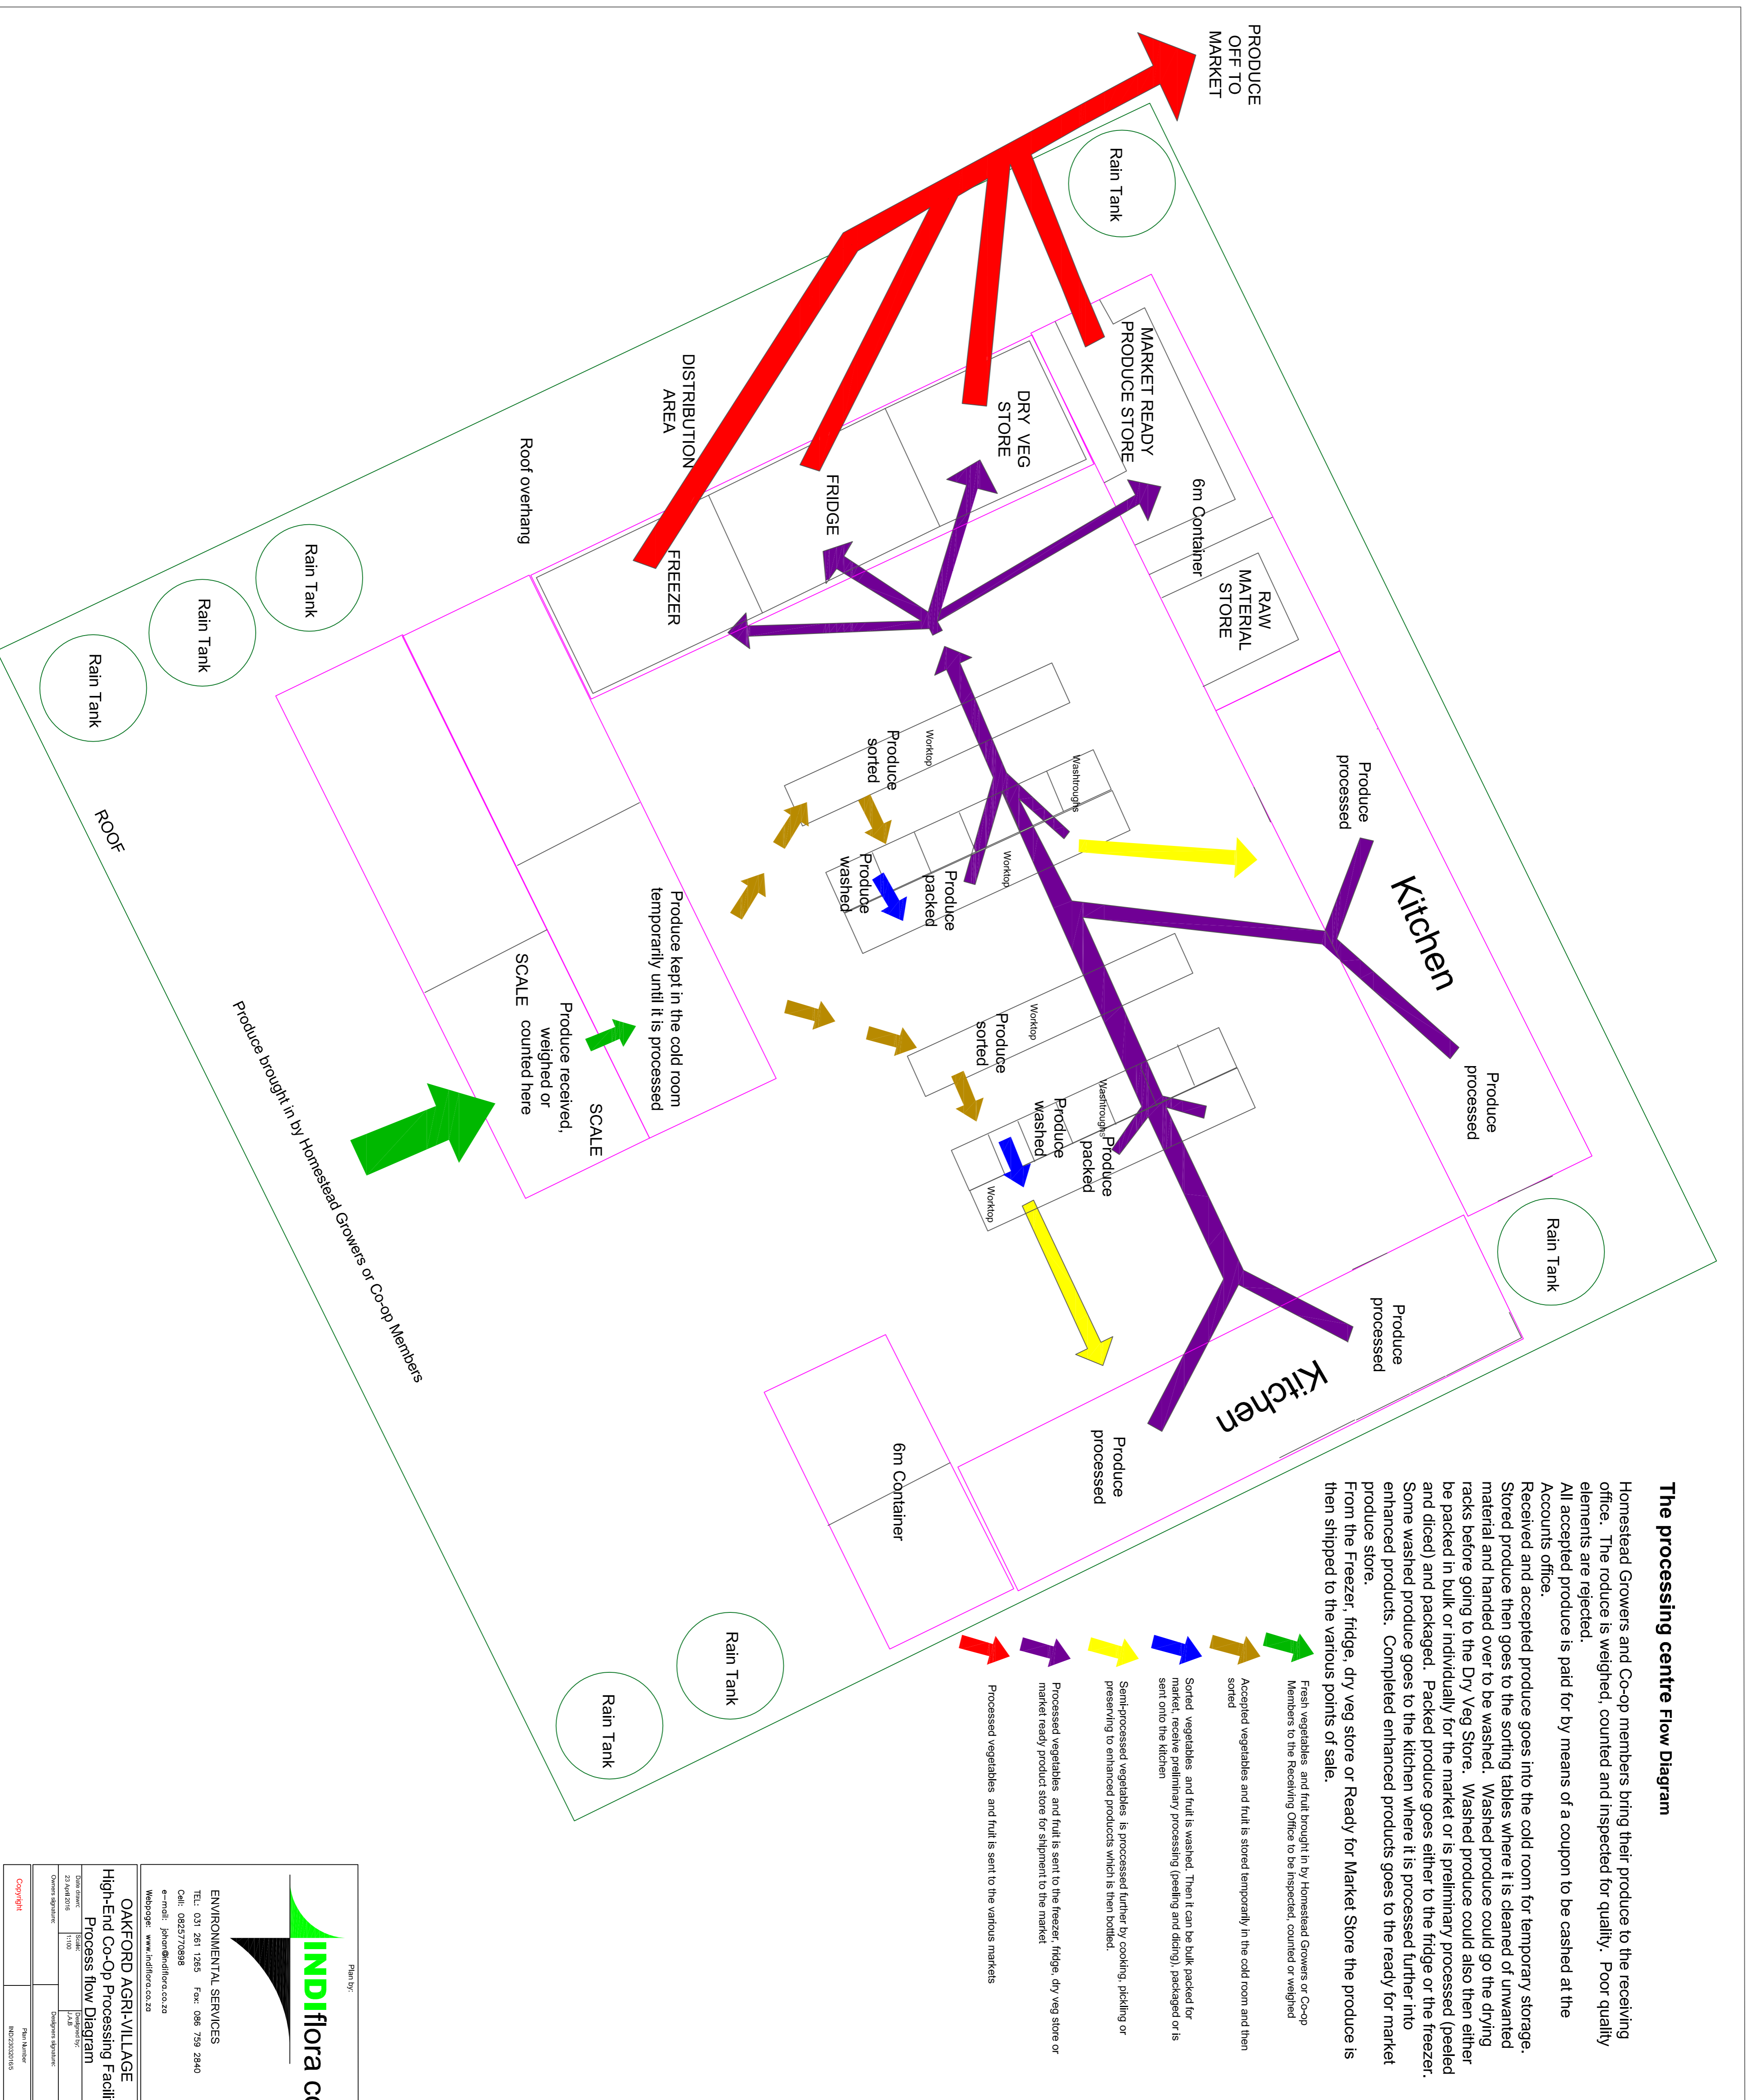

Priority
INDIFlora CC

ENVIRONMENTAL SERVICES
TEL: 031 261 1265 Fax: 085 759 2840
CALL: 0825770898
e-mail: john@indiflora.co.za
Webpage: www.indiflora.co.za

OAKFORD AGRI-VILLAGE
High-End Co-Op Processing Facility
Process flow Diagram

Date issued:	23 Aug 2018	Scale:	A3
Client:	INDIFlora	Project No:	IND20180165
Drawn by:	J.A.B	Designed by:	J.A.B
Checked by:	J.A.B	Printed by:	J.A.B

Copyright